

 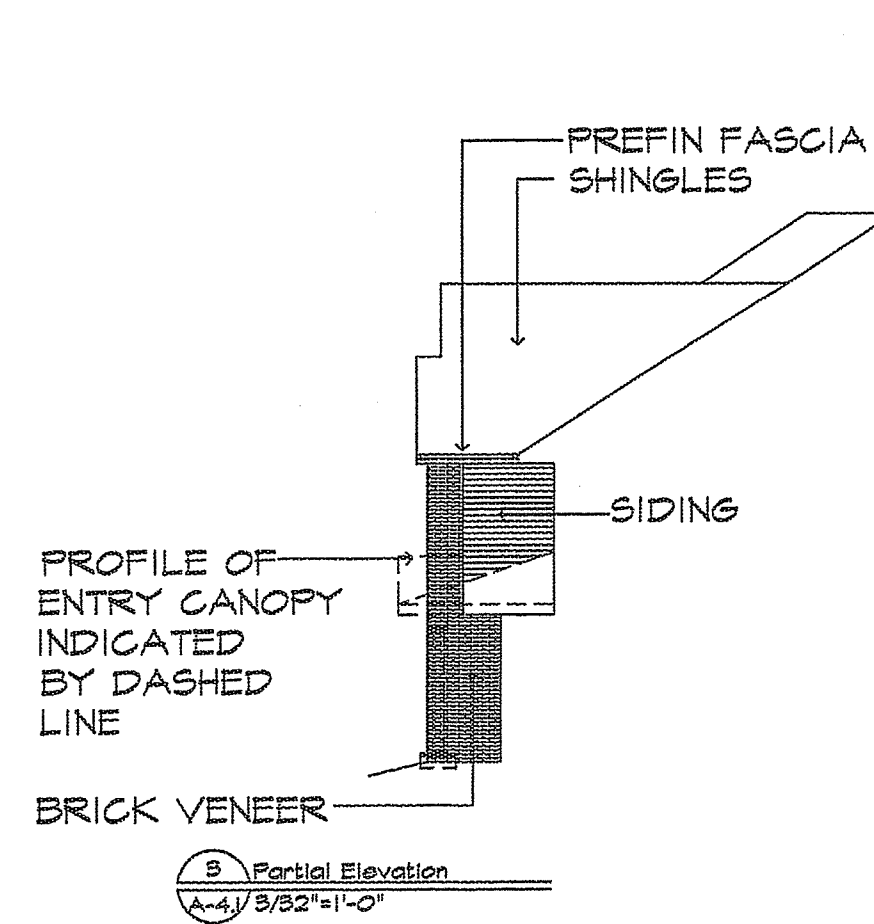
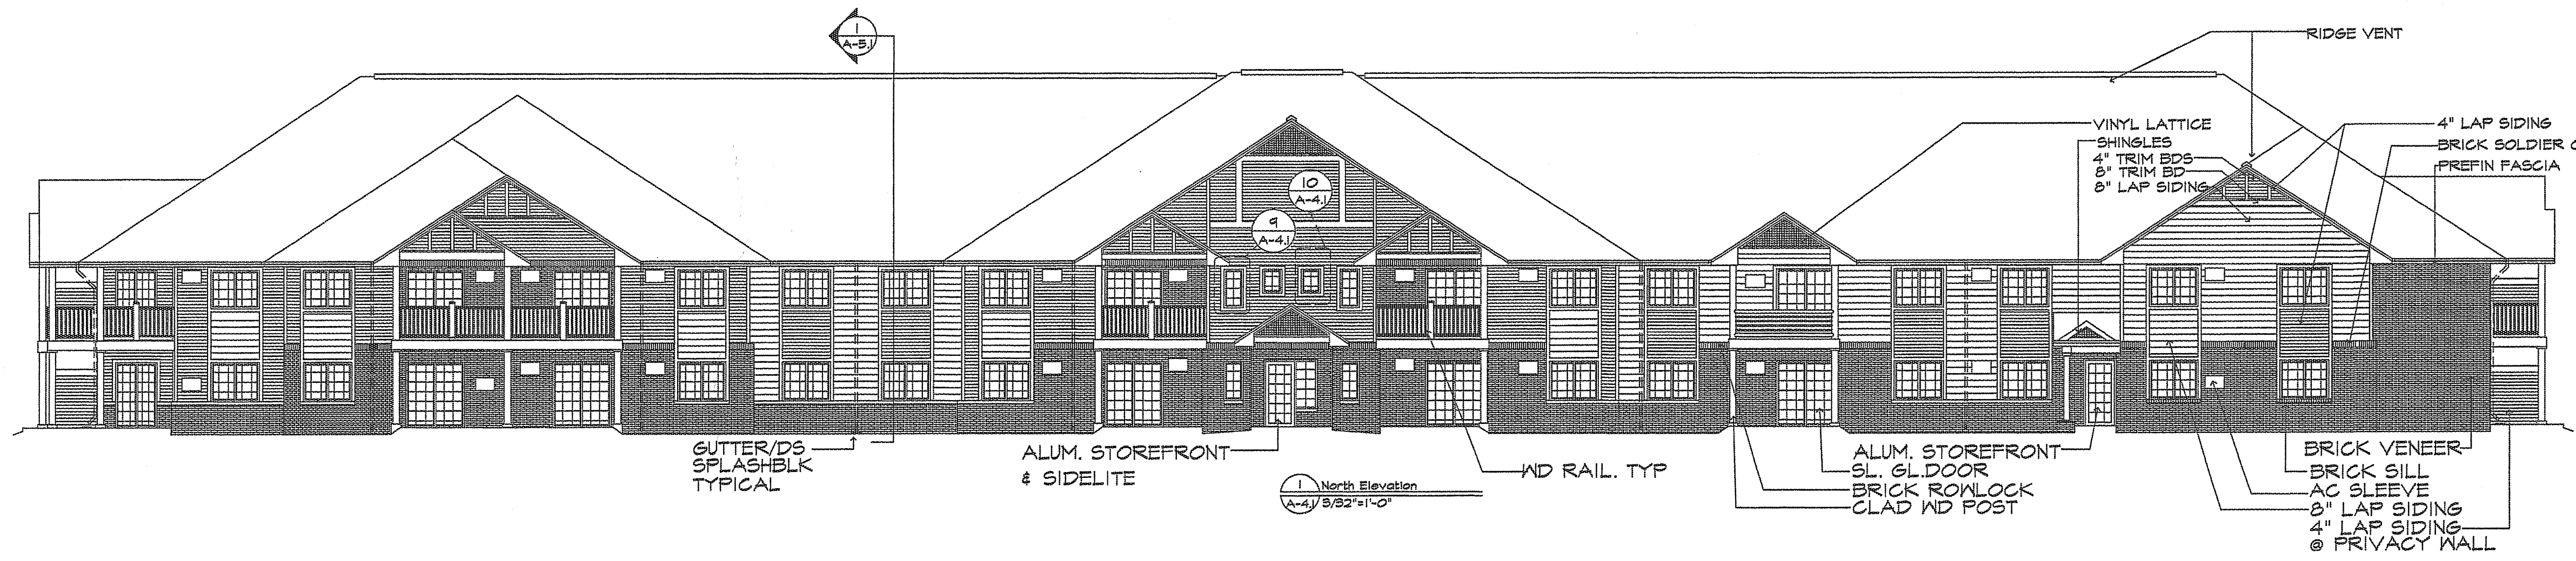

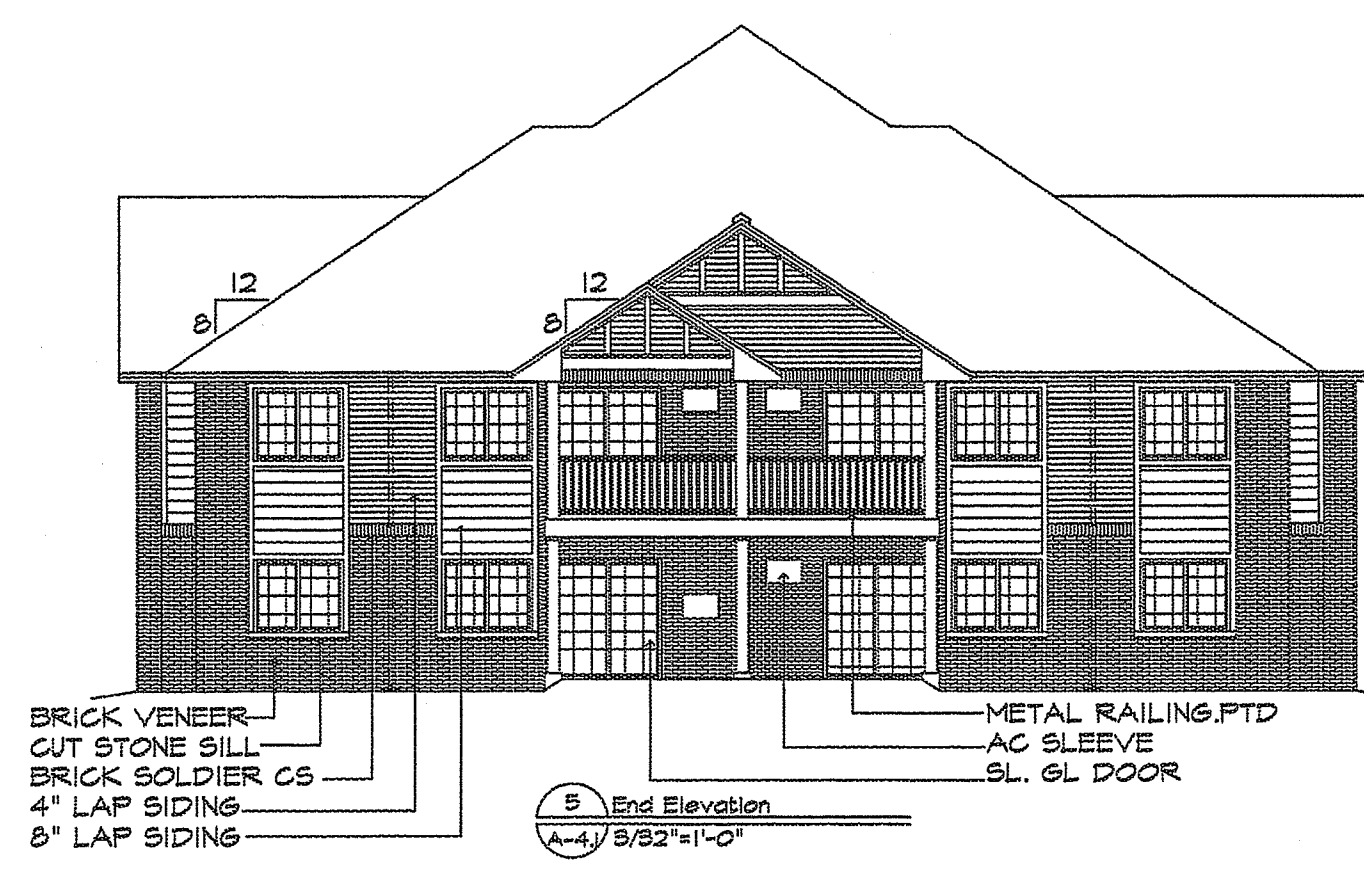
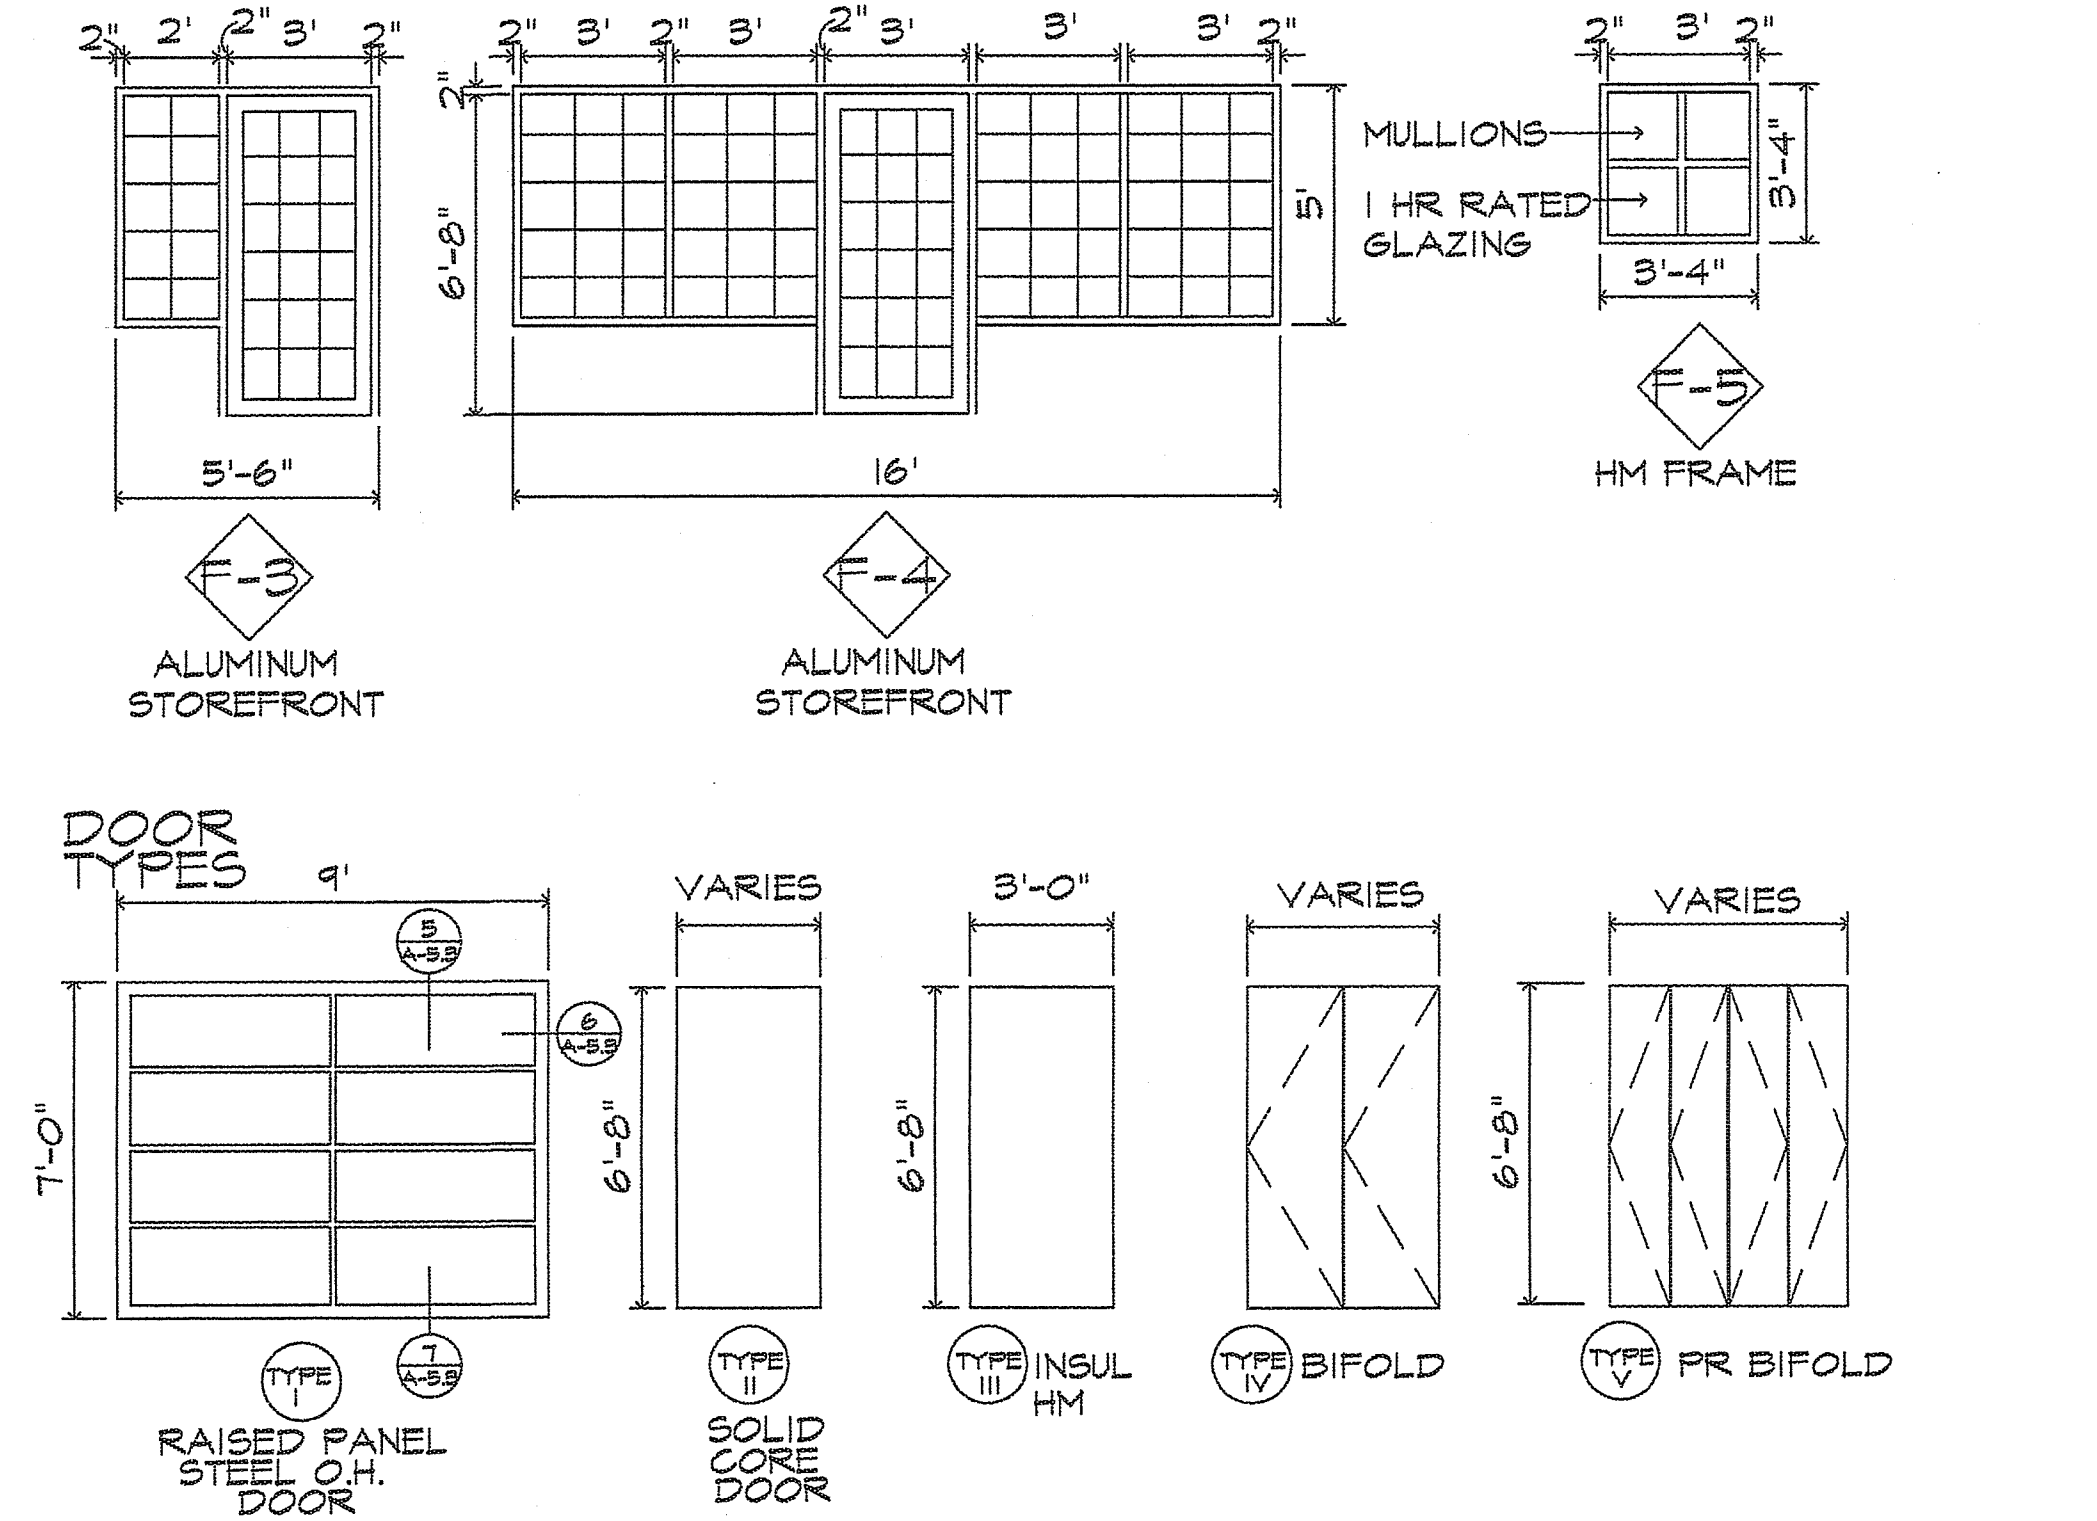
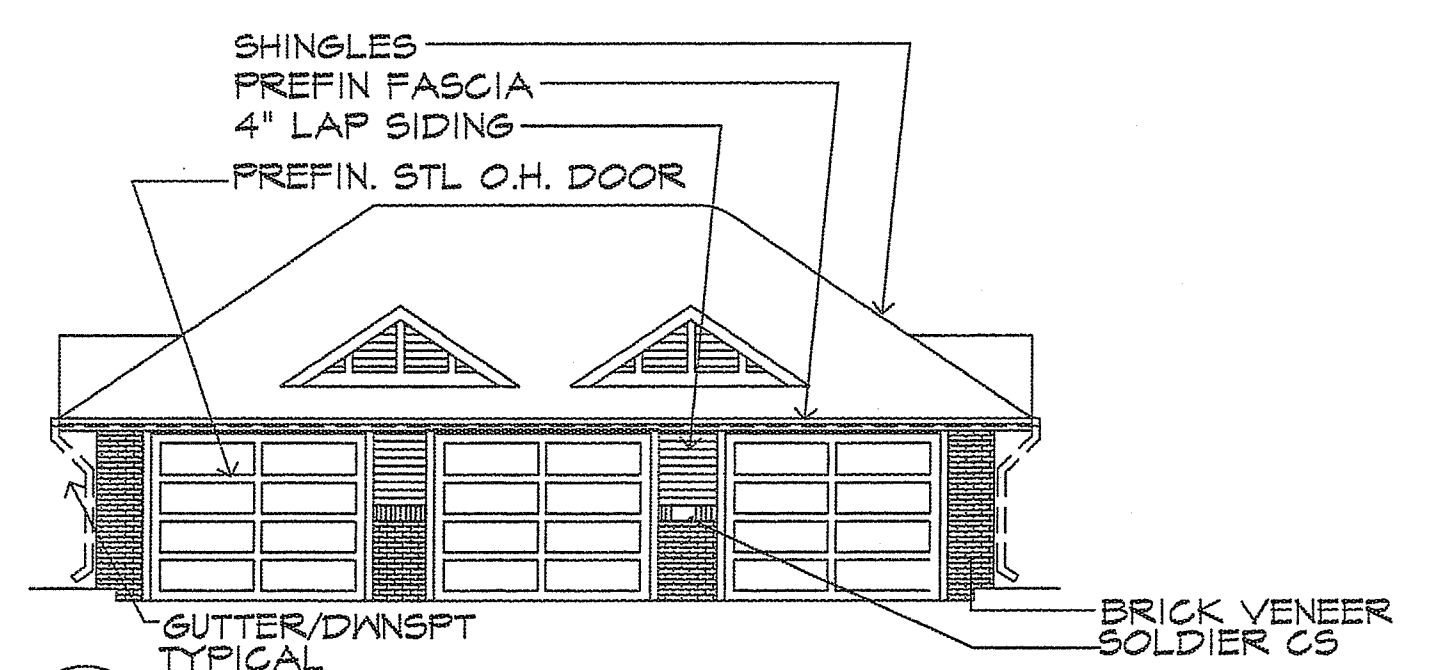


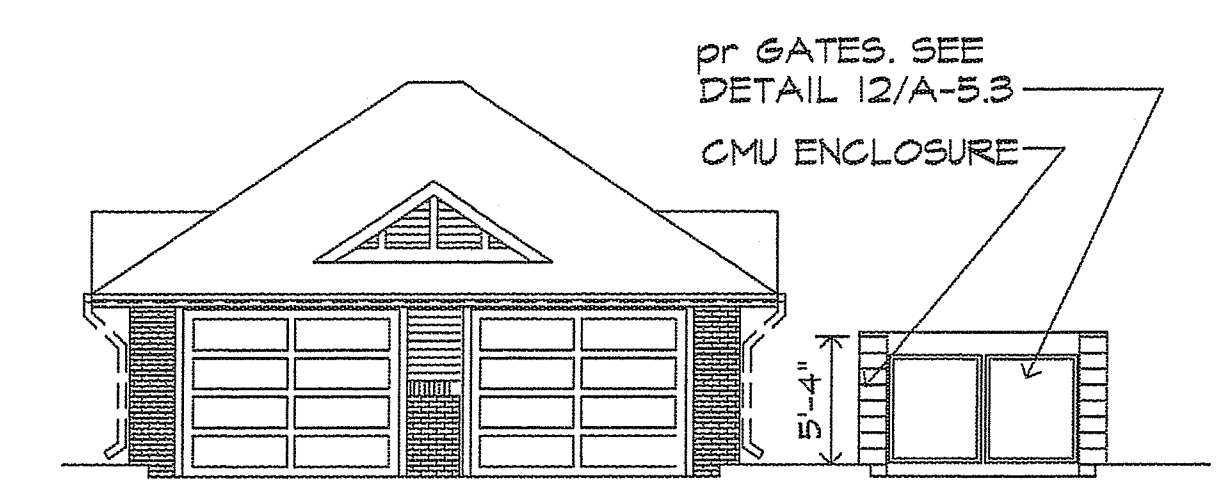

Building Elevations









SWISSHELM VILLAGE APARTMENTS III
St. Cloud, Minnesota
St. Cloud Housing and Redevelopment Authority

[illegible]

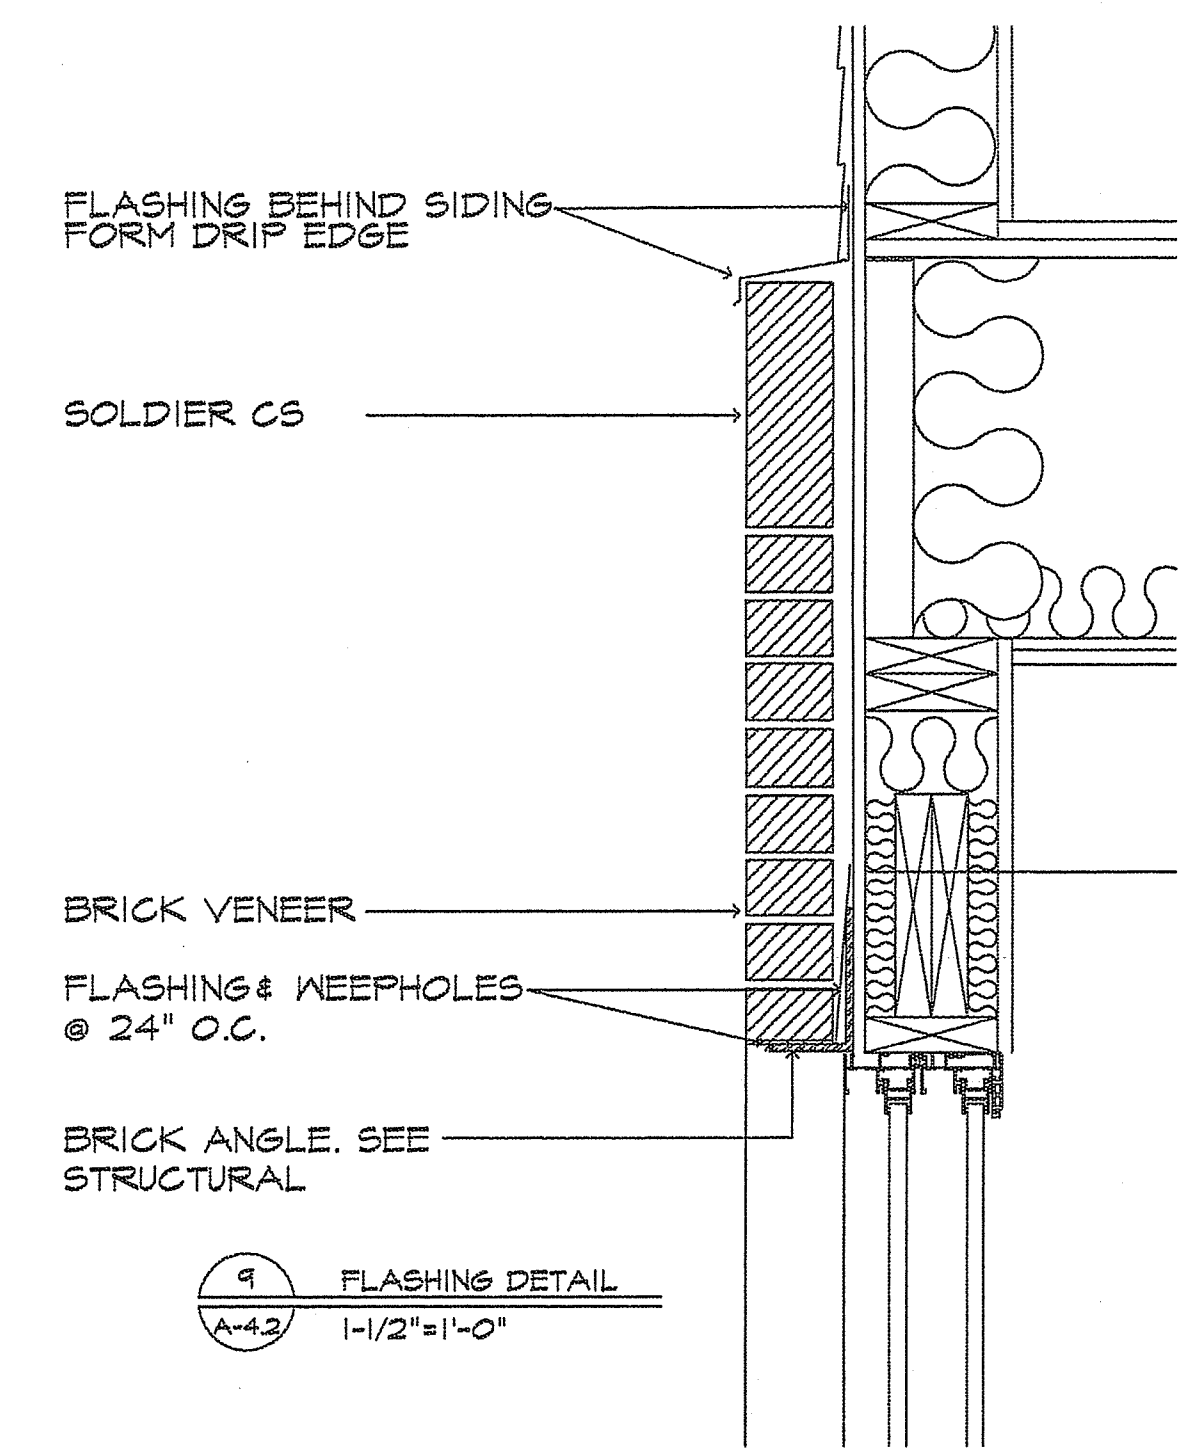

5 Garage Plan-3 Stalls
A-4.2 1/8" = 1'-0" 931 GROSS SF

BRICK VENEER _____
SOLDIER CS _____
GUTTER/DS.TYP _____

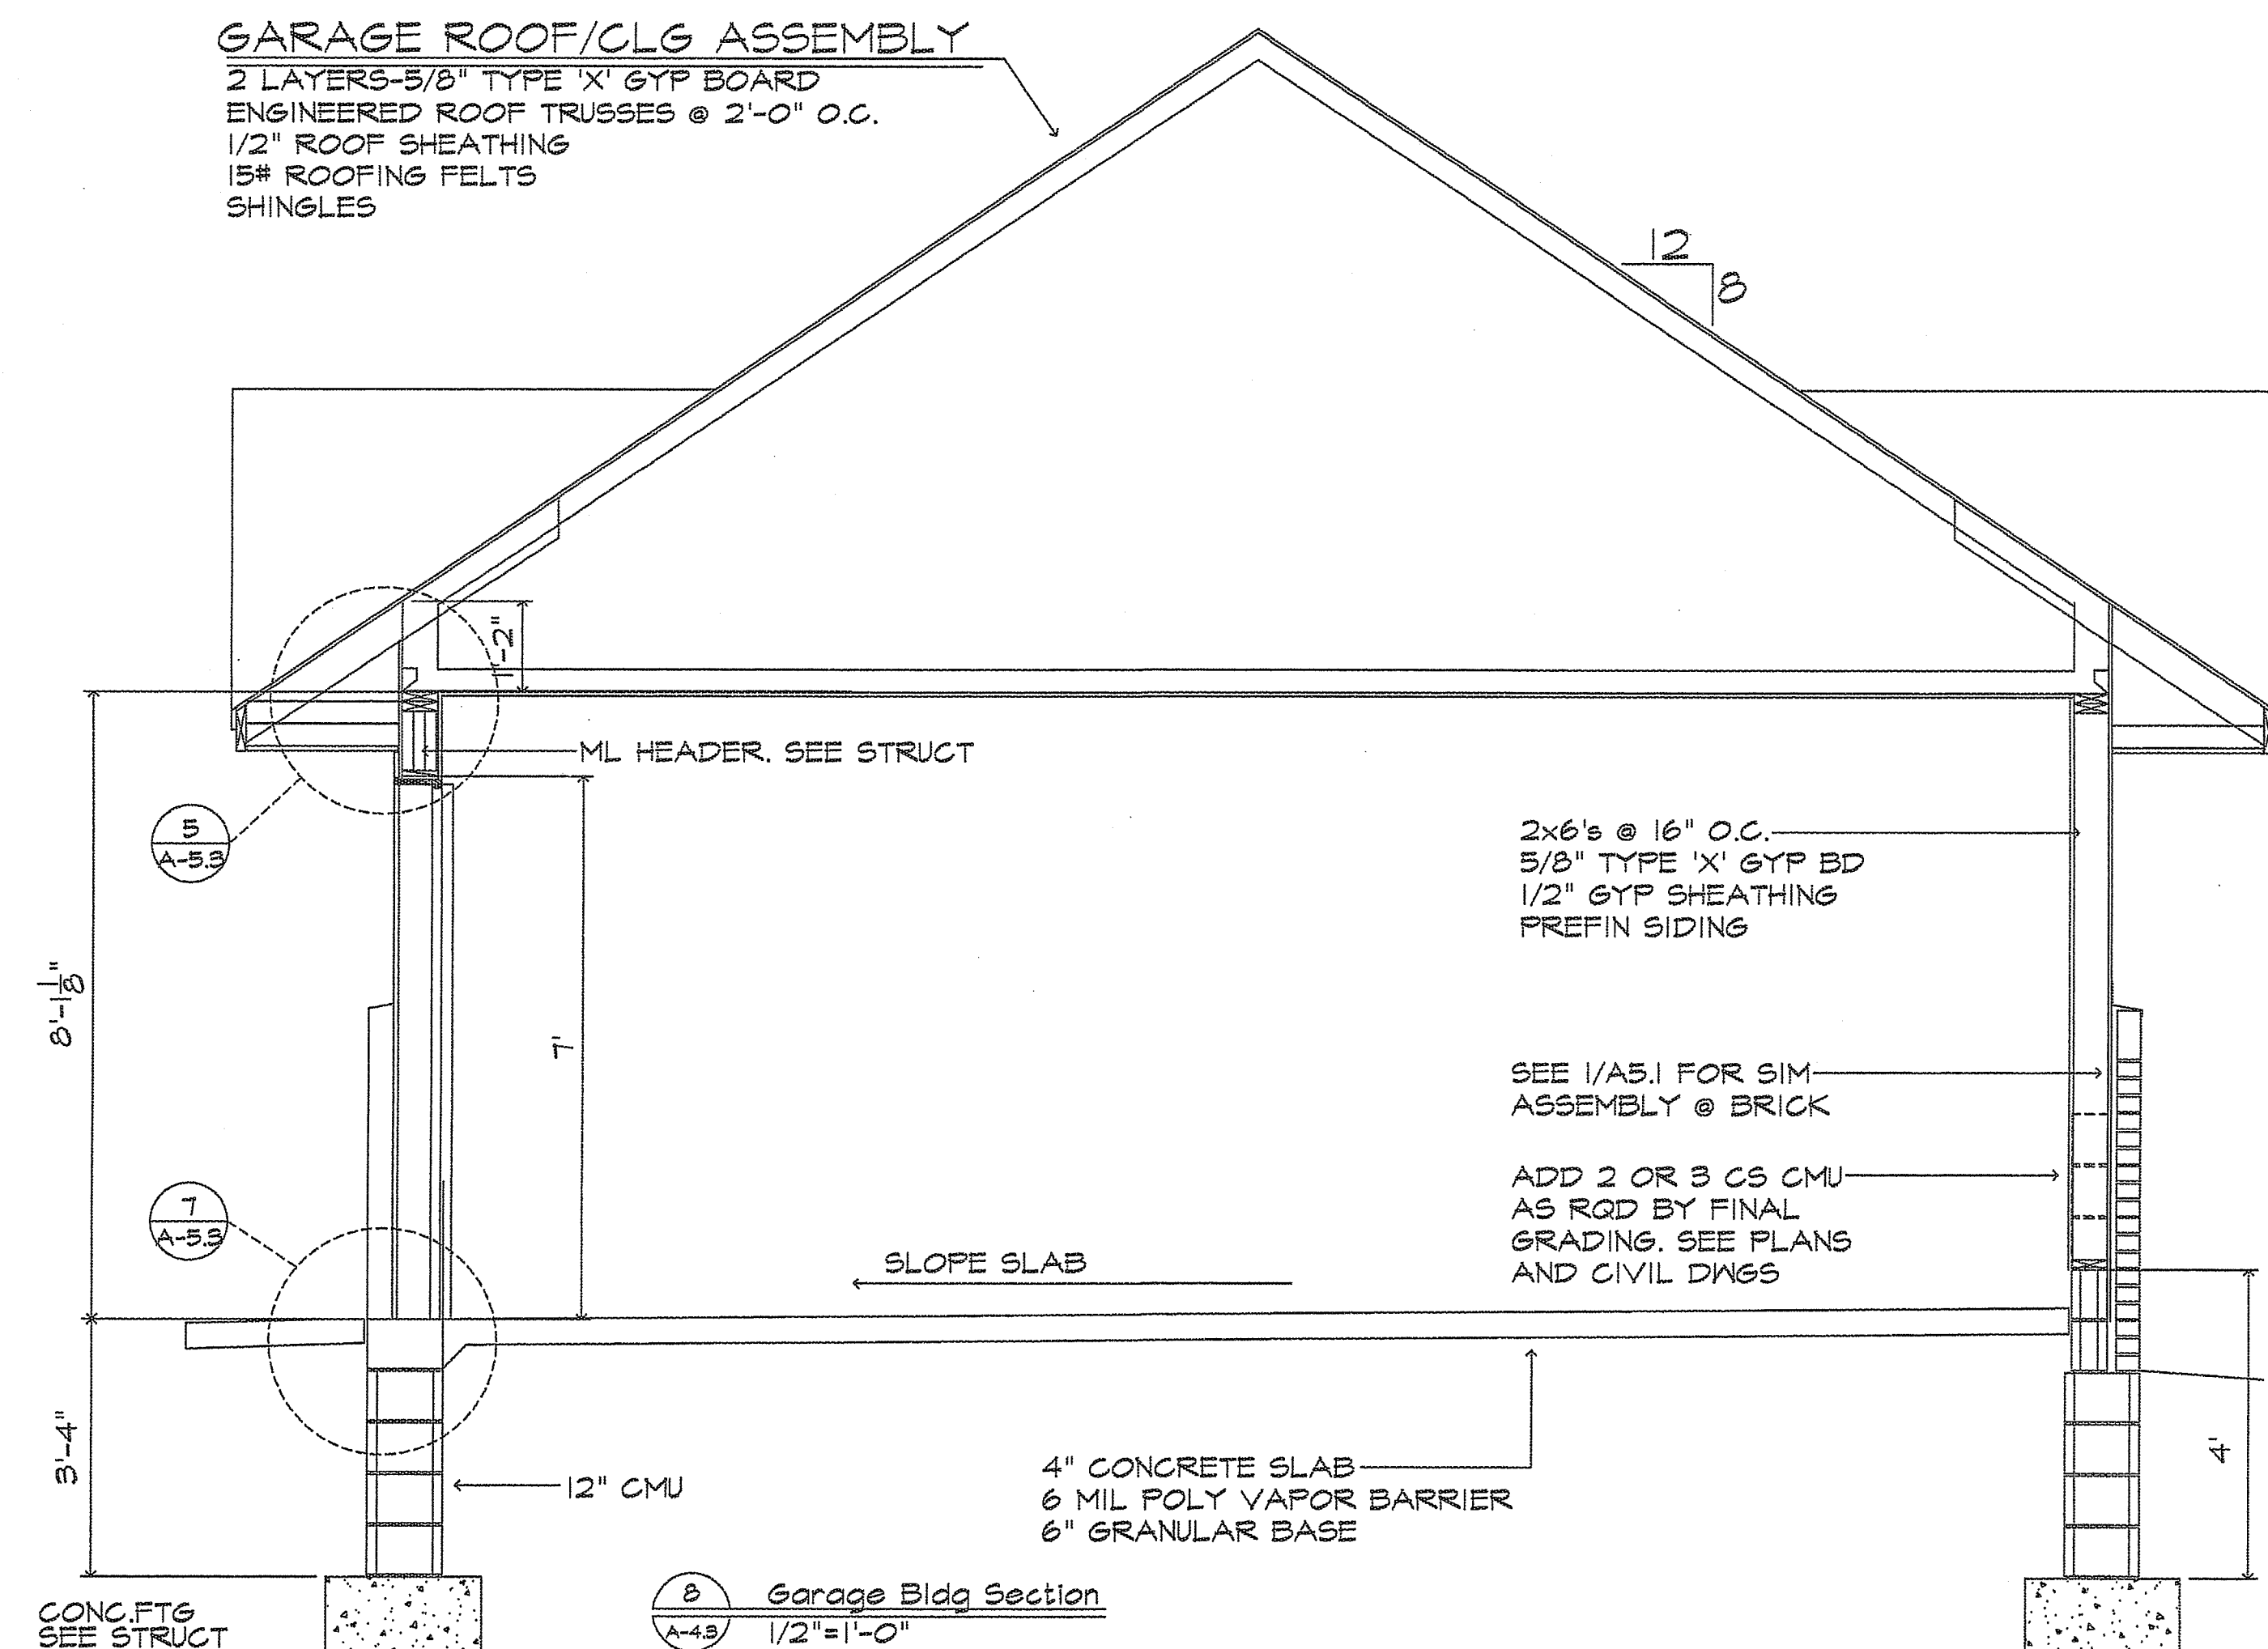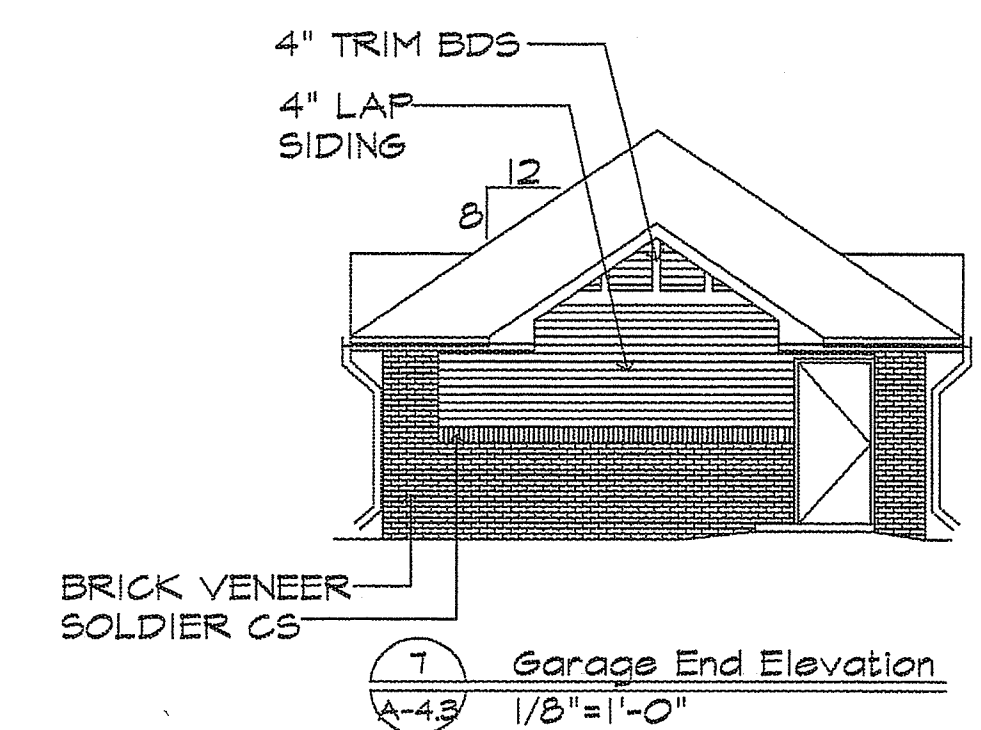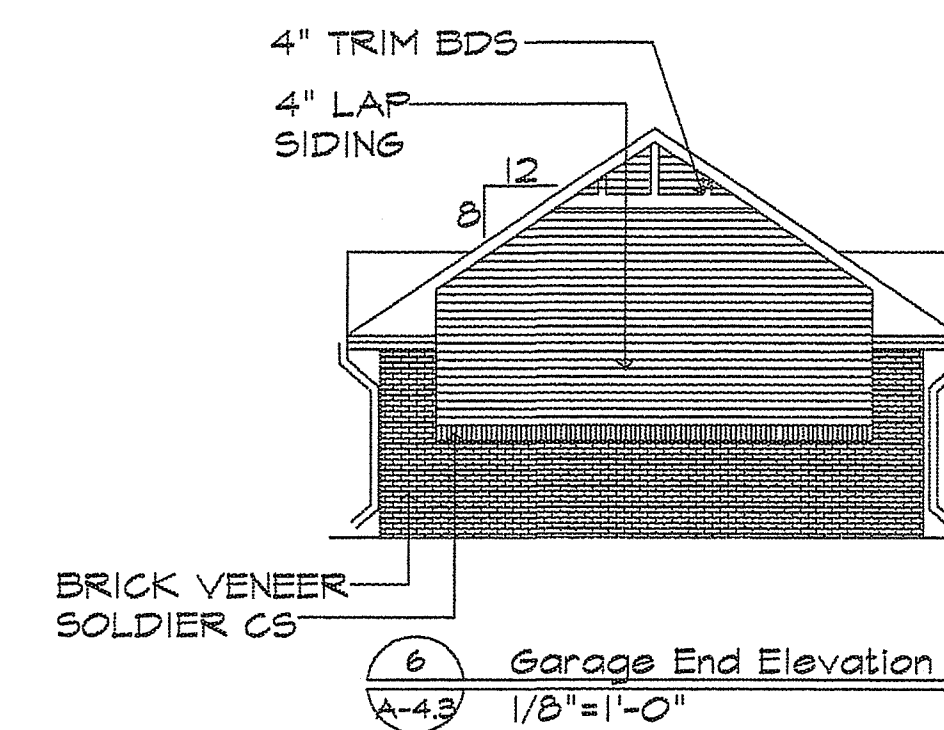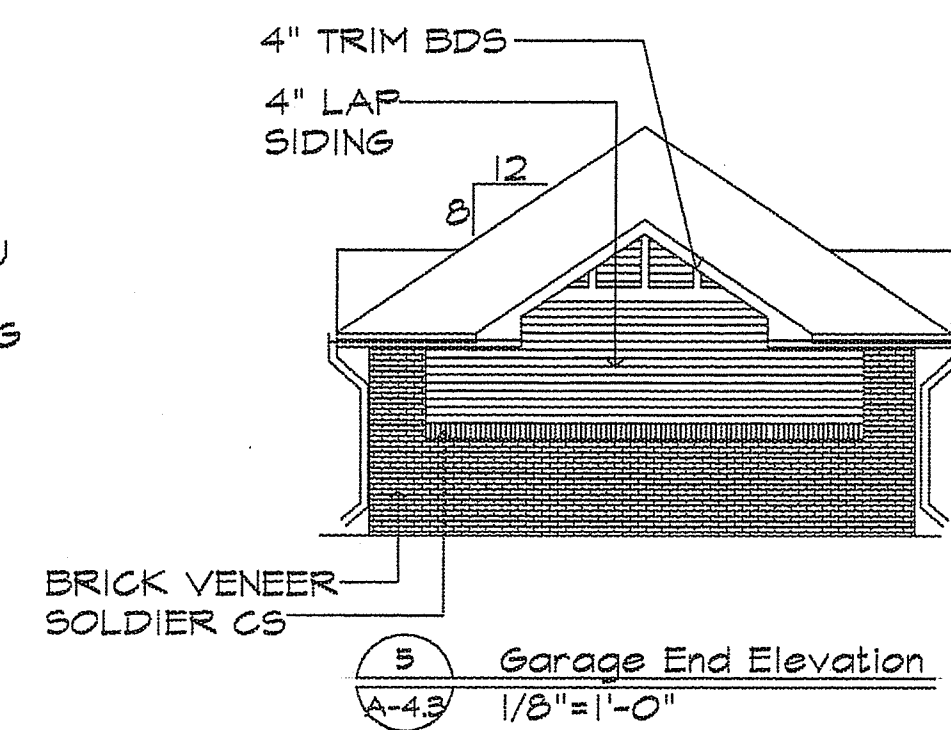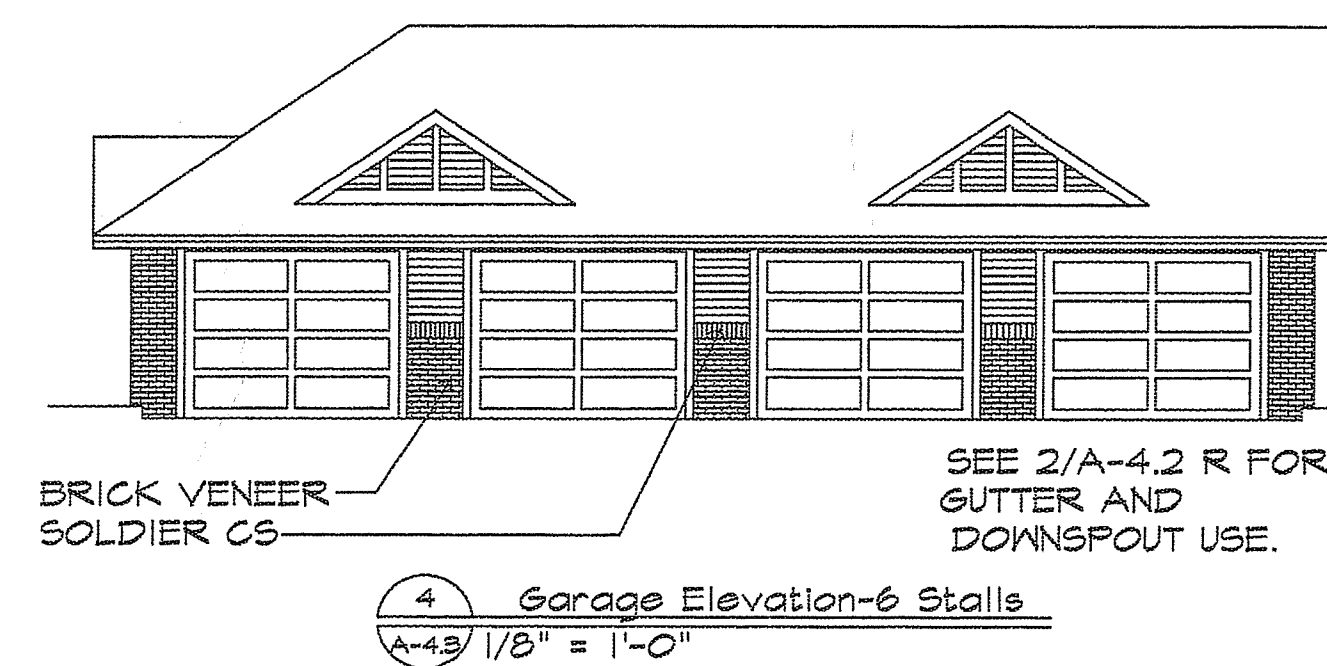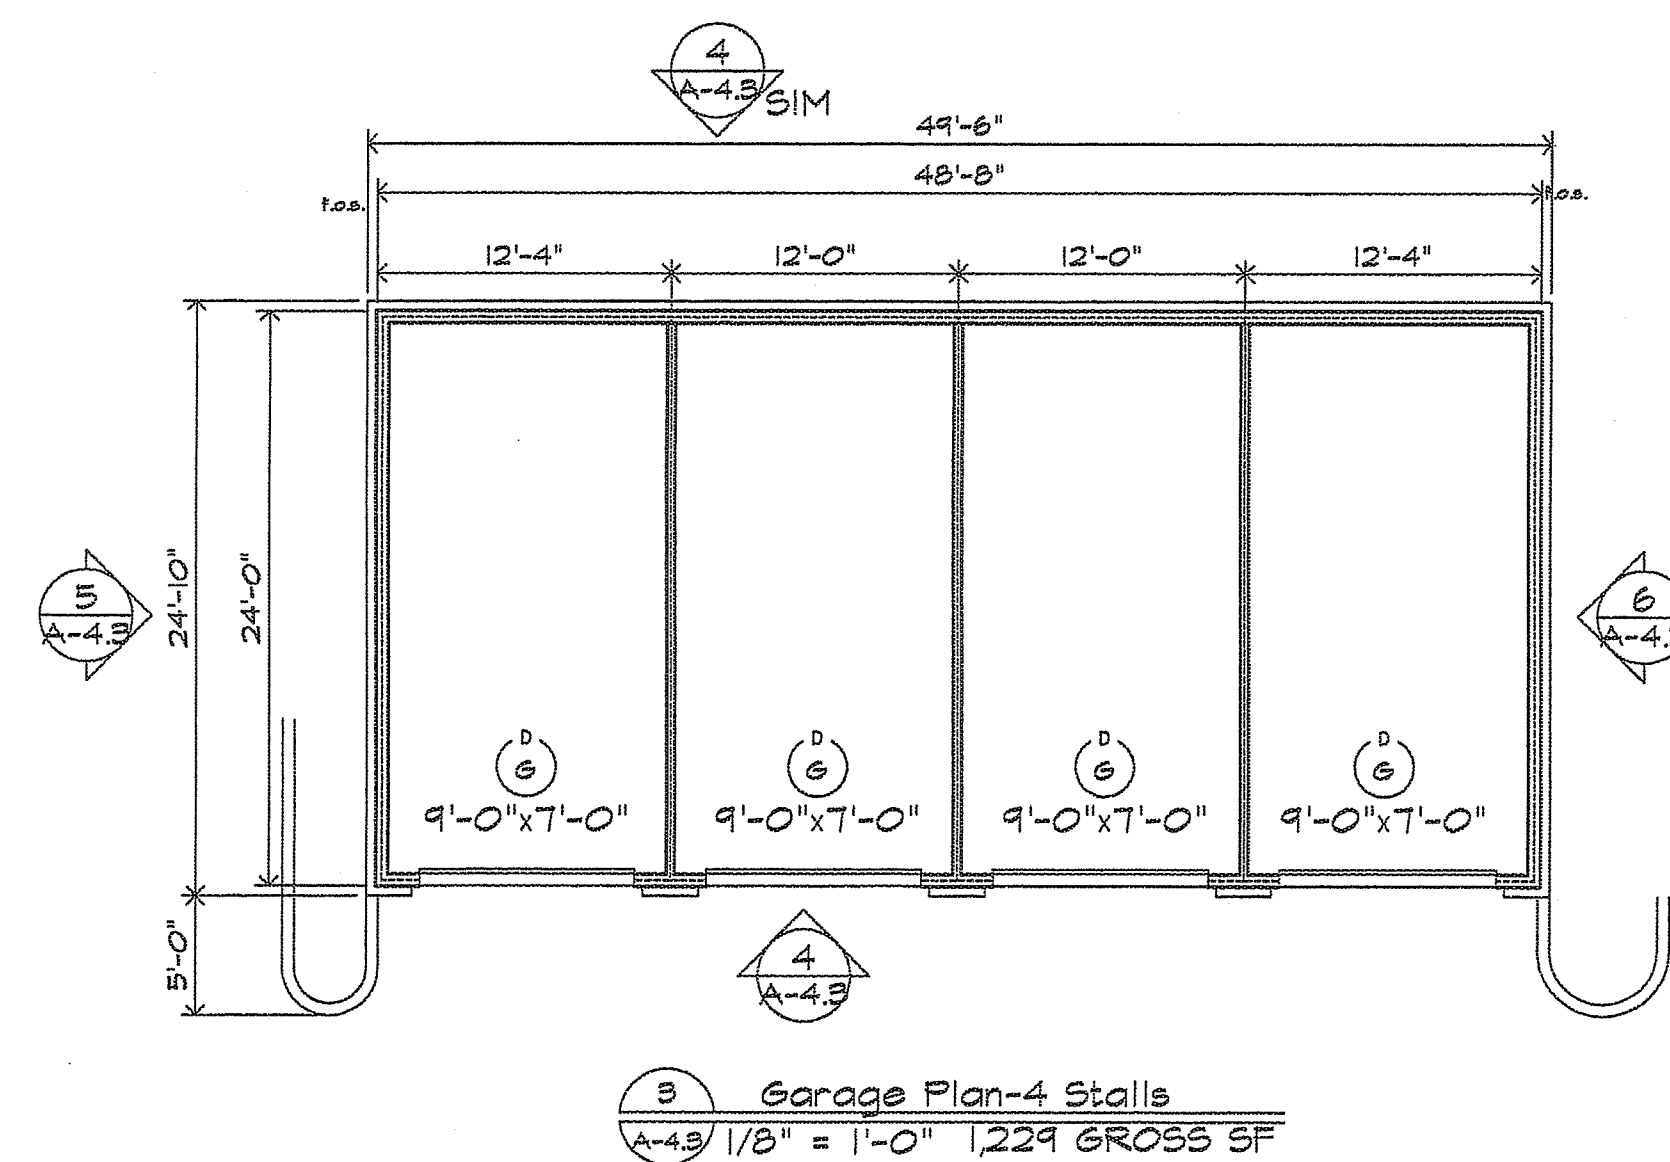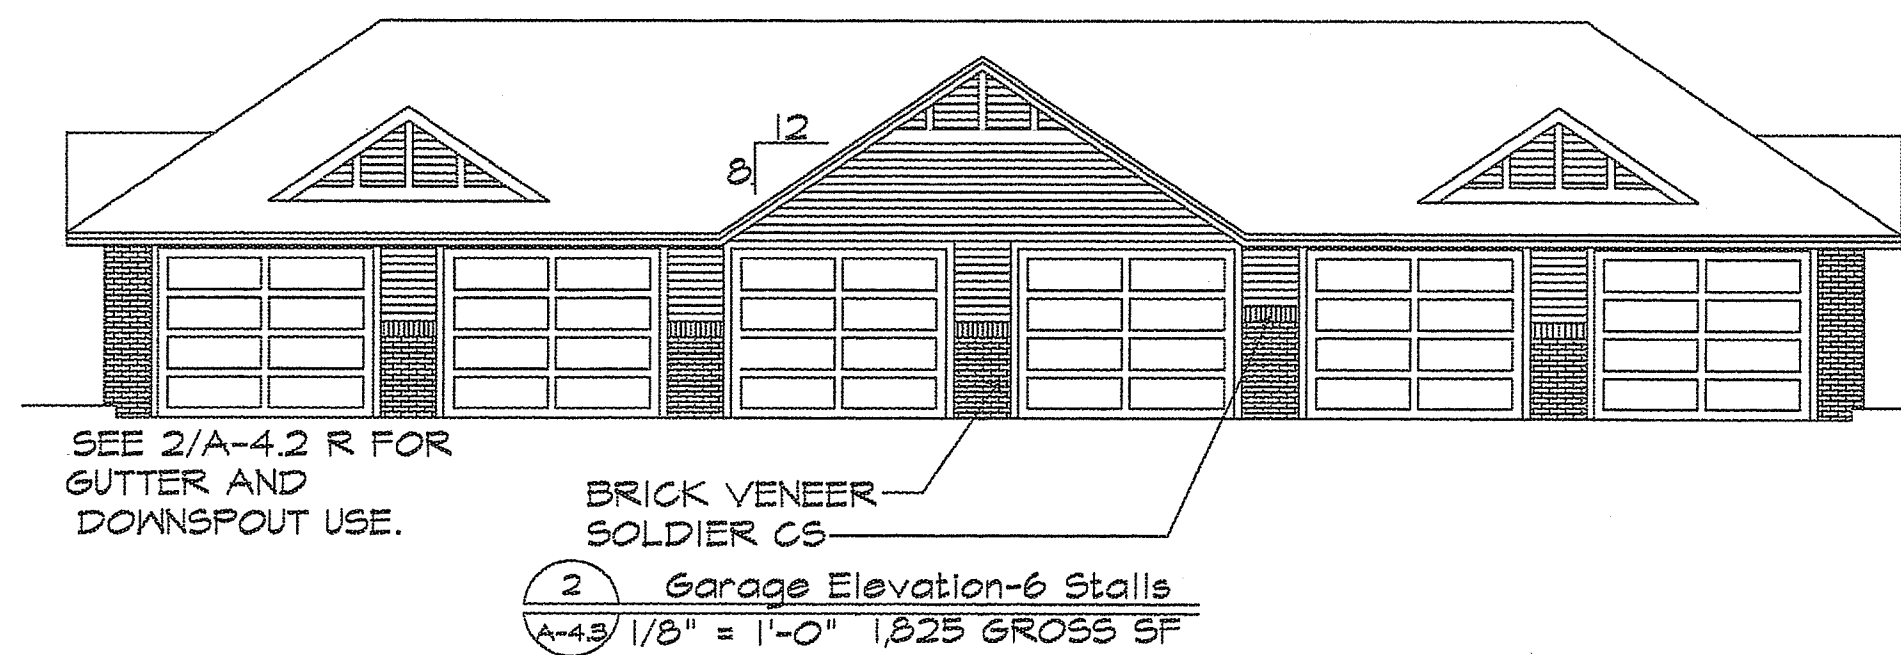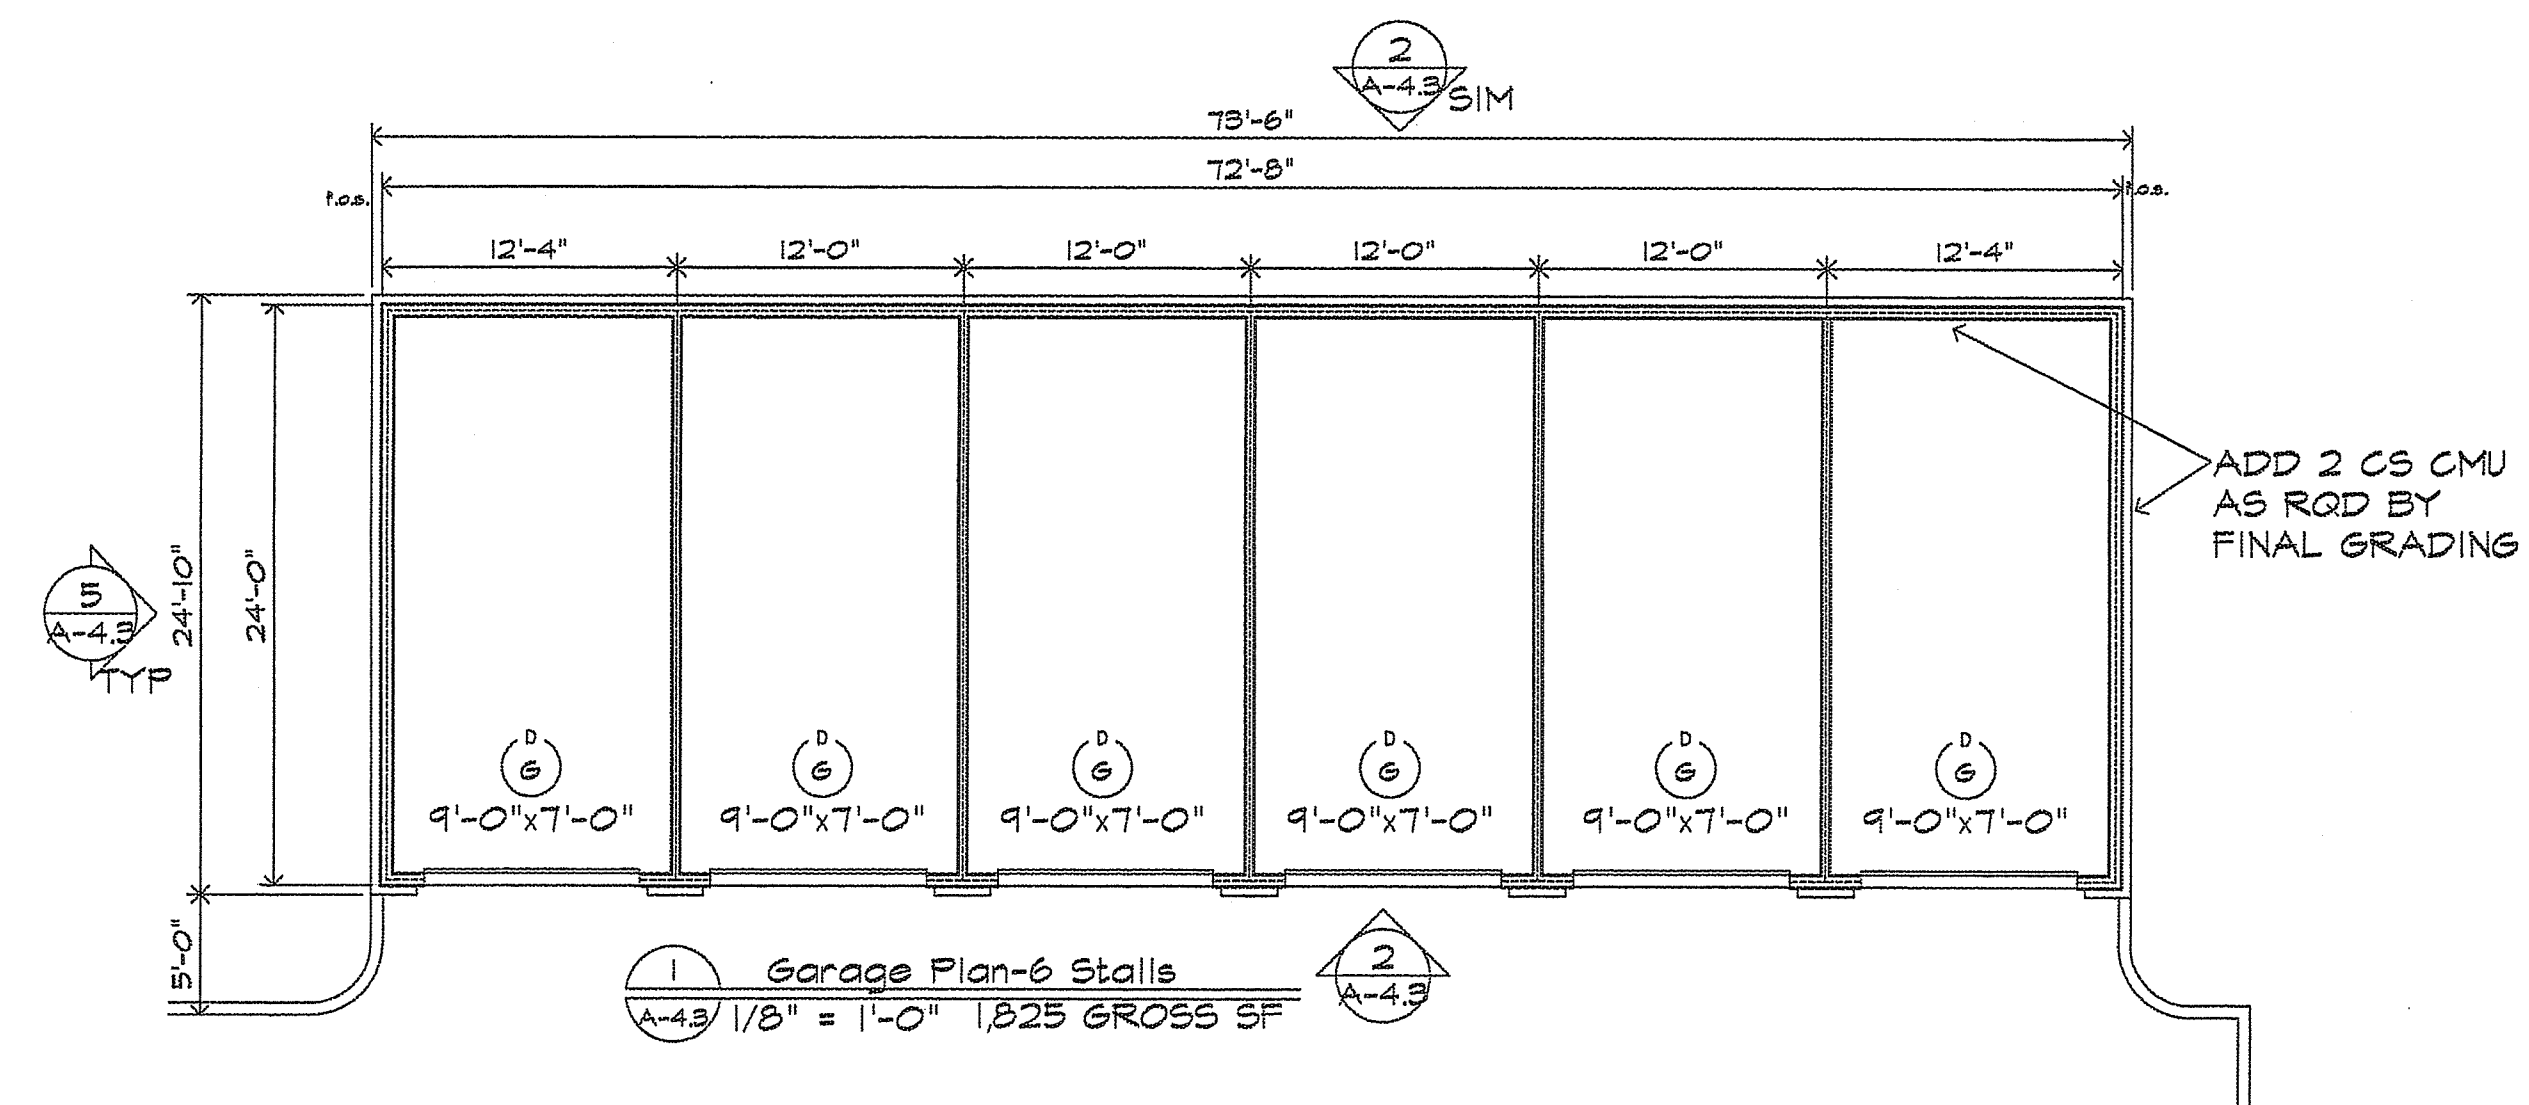[illegible]



STEVEN M. YERGEN
REGISTRATION NO. 16544

619 W. ST. GERMAIN STREET
SUITE 212
ST. CLOUD, MN 56301
(320) 252-0880
FAX (320) 252-0889

ELECTRICAL SITE PLAN

SWISSHELM VILLAGE APARTMENTS II
St. Cloud, Minnesota

St. Cloud Housing and Redevelopment Authority

REVISIONS		
NO.	DATE	DESCRIPTION

DATE 2/8/08




PROJECT NO. PBASO!

FILE


DRAWN BY SMT/TTP

PLOTTED

SHEET NO.

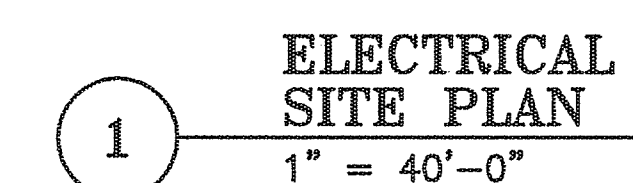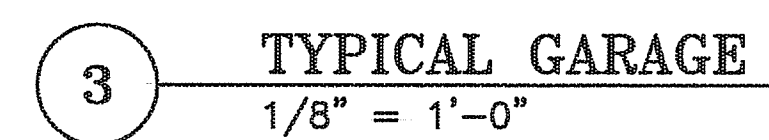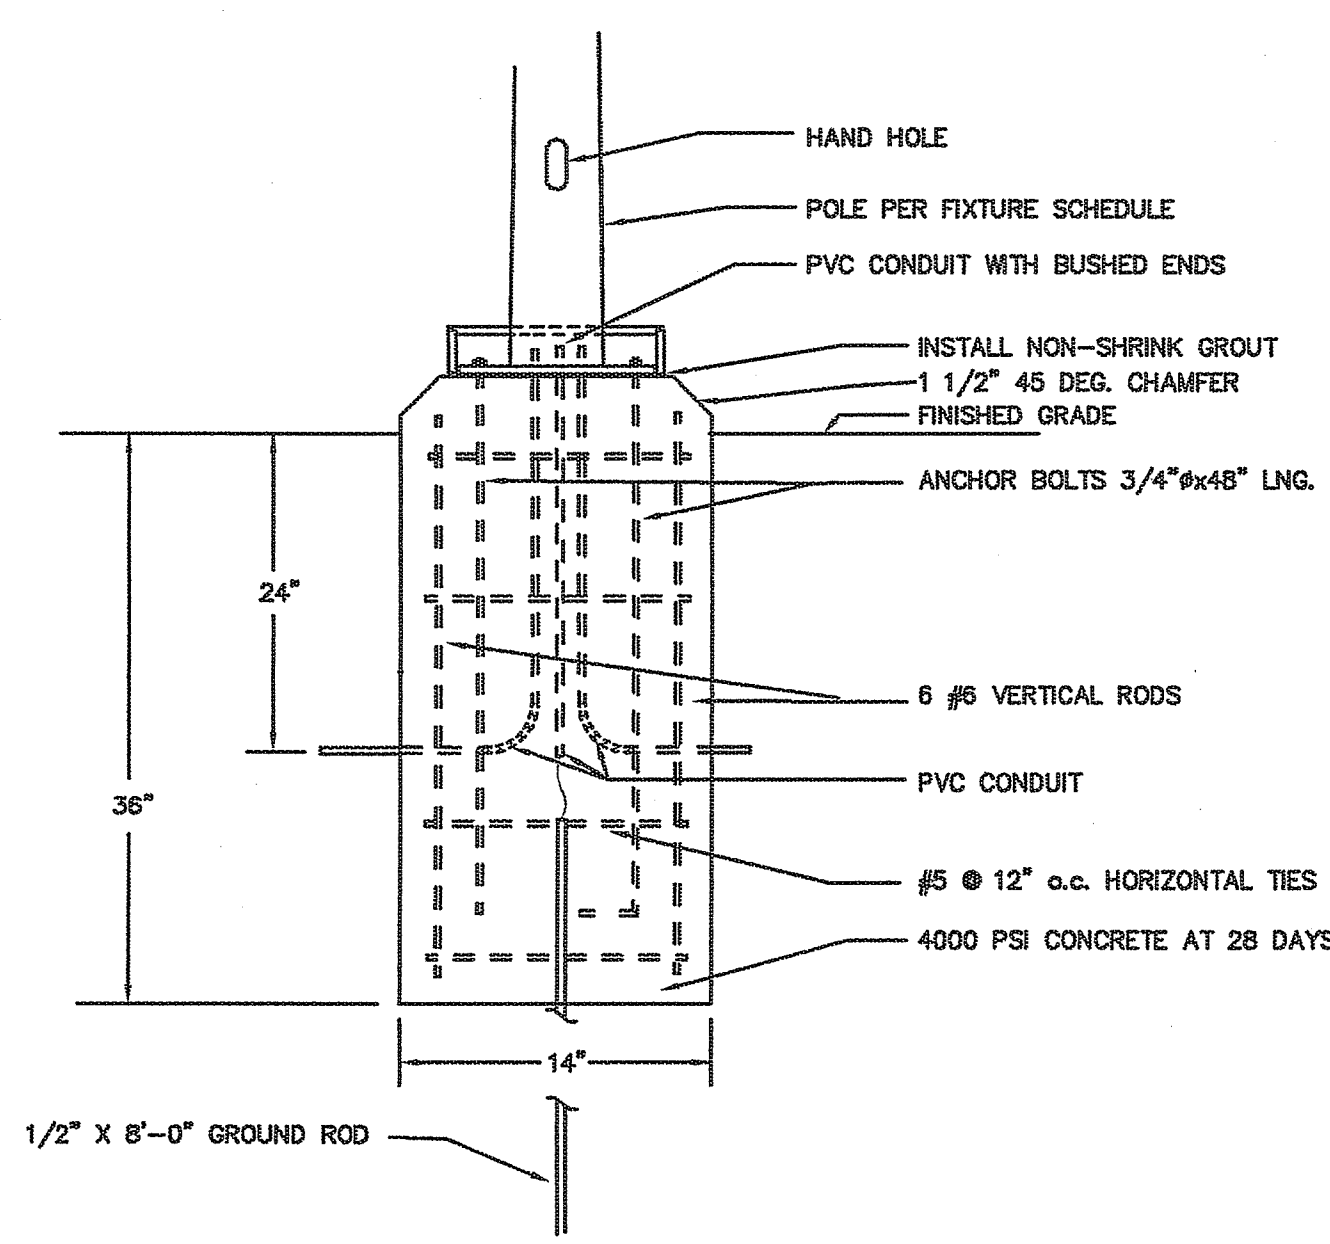[illegible]

2 POLE BASE DETAIL
NO SCALE

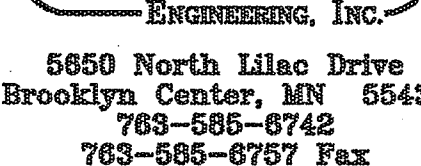

PBA Architects Inc.
2745 NORTH EVEREST LANE
Plymouth, Minnesota 55447
(182) 418-8750 / Fax (182) 418-4038

I HEREBY CERTIFY THAT THIS PLAN SPECIFICATION OR REPORT WAS PREPARED BY ME & UNDER MY DIRECT SUPERVISION THAT I AM FULLY REGISTERED ENGINEER UNDER THE LAWS OF THE STATE OF MINNESOTA.

Steven M. Z...

REGISTRATION NO. 1654

ST. CLOUD



BEARING AND DEVELOPMENT AUTHORITY

619 W. ST. GERMAIN STREET
SUITE 212
ST. CLOUD, MN 56301
(320) 252-0880
FAX (320) 252-0889

SECOND FLOOR LIGHTING PLAN

SWISSHELM VILLAGE APARTMENTS II
St. Cloud, Minnesota

REVISONS		
NO.	DATE	DESCRIPTION
DATE 2/15/08		
PROJECT NO. PBASCI		
FILE		
DRAWN BY SMT/TTP		
PLOTTED		
SHEET NO.		

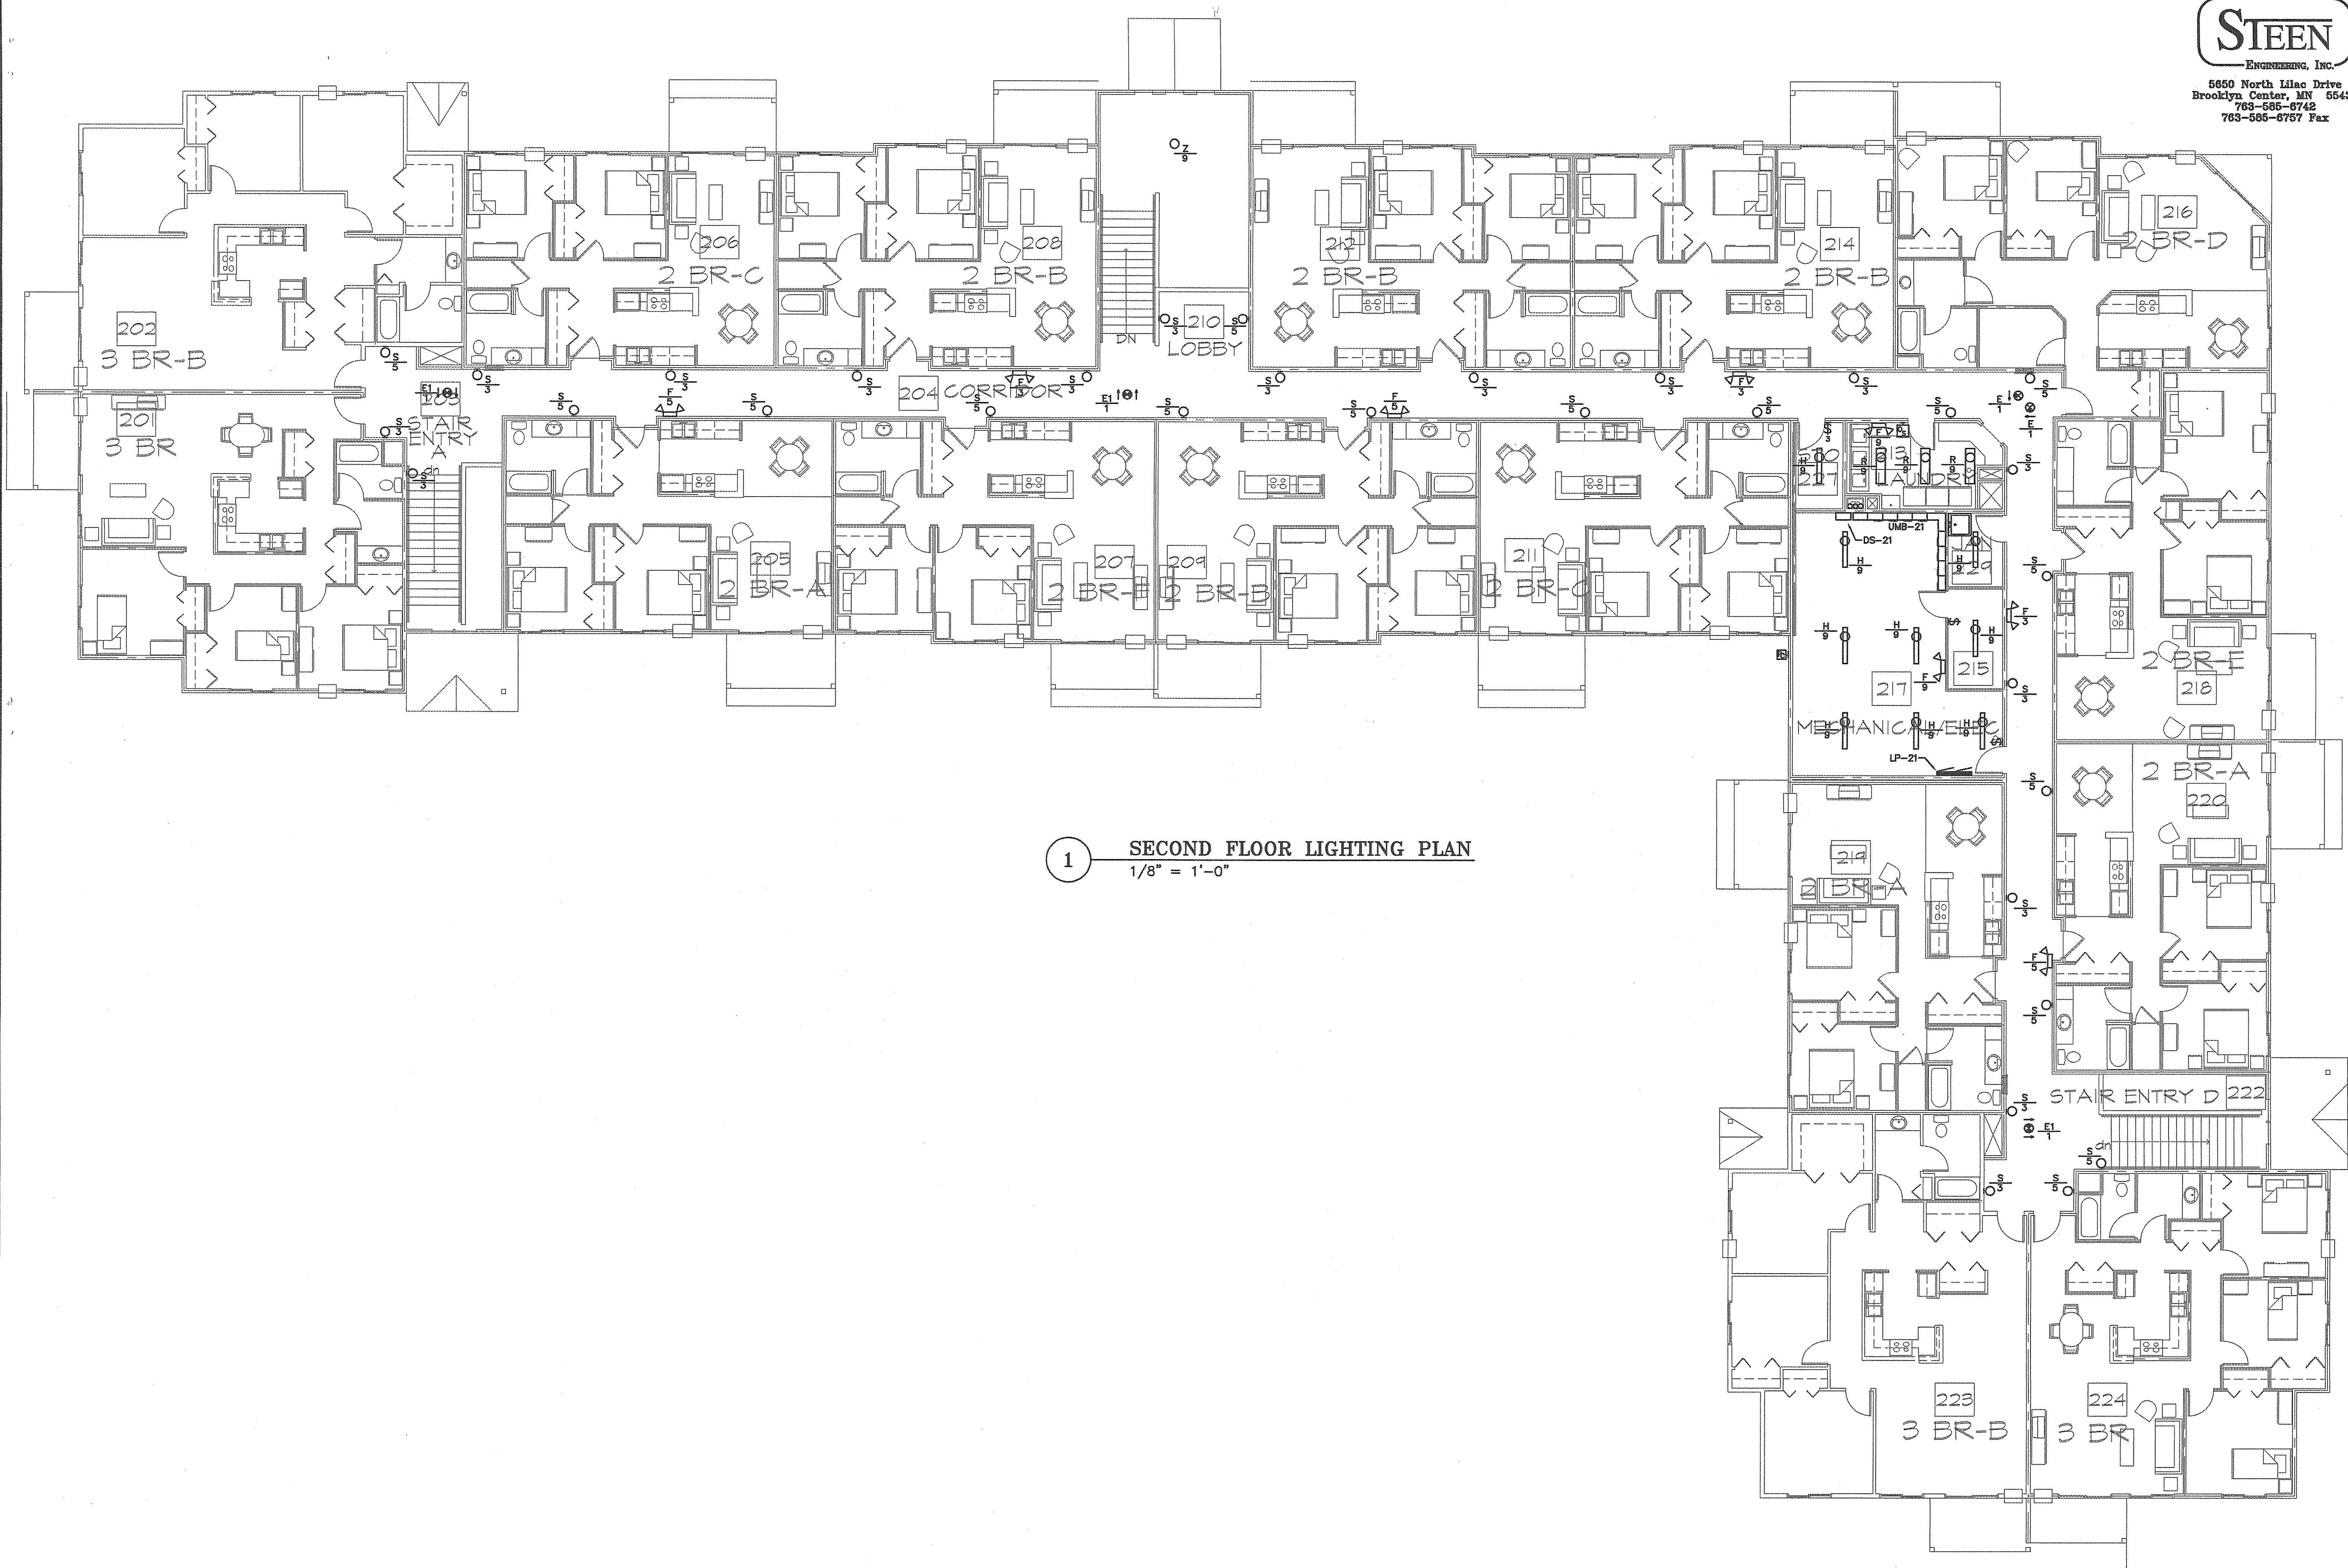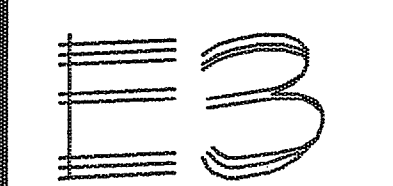

1 SECOND FLOOR LIGHTING PLAN
1/8" = 1'-0"



**DUFFY ENGINEERING
AND ASSOCIATES, INC.**
STRUCTURAL - CIVIL - SURVEYING
1424 2nd Street North
Sauk Rapids, MN 56379
Phone: (320) 254-6575
Fax: (320) 254-6491
Email: mail@duffyeng.com